


1 BASEMENT ELECTRICAL PLAN
SCALE: 1/8" = 1'-0"

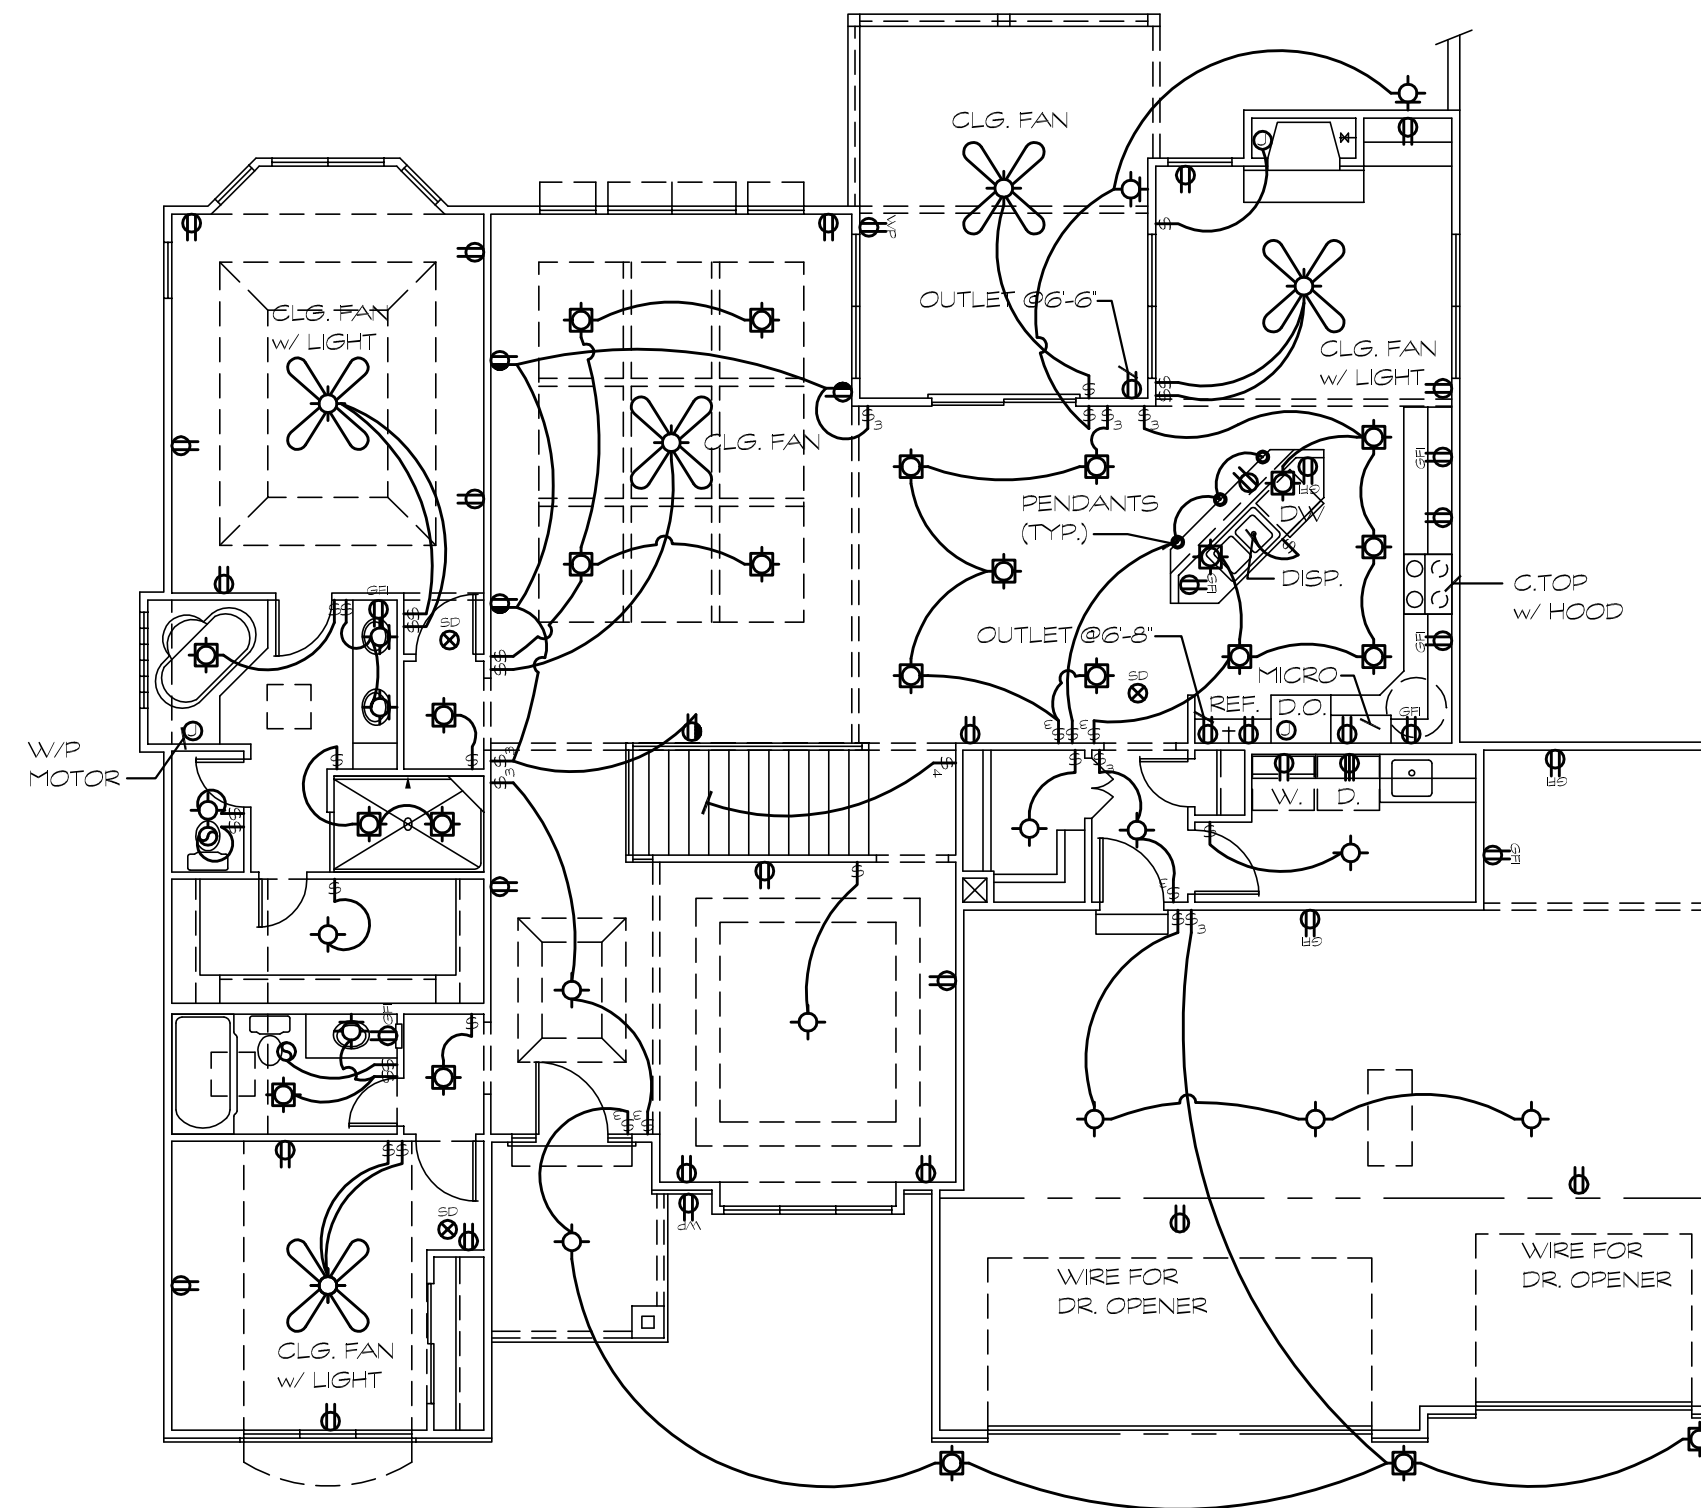


2 MAIN LEVEL ELECTRICAL PLAN
SCALE: 1/8" = 1'-0"

ELECTRICAL LEGEND			
	WALL MOUNT LIGHT		2-WAY SWITCH
	FLOOD LIGHT		3-WAY SWITCH
	SURFACE MOUNT LIGHT		4-WAY SWITCH
	SMOKE DETECTOR		TELEPHONE JACK
	GROUND FAULT OUTLET		CEILING FAN w/ LIGHT
	WATERPROOF OUTLET		
	220V OUTLET		CABLE TELEVISION
	110V OUTLET		FAN / LIGHT COMBO
	EXHAUST FAN		ELECTRICAL PANEL
	SWITCHED 110V OUTLET		MINI CAN
	CAN LIGHT		DOOR BELL
	JUNCTION BOX		PULL CHAIN LIGHT

NOTE: PROVIDE TELEPHONE AND CABLE TELEVISION OUTLETS AS PER OWNER / CONTRACTOR

KEN TINNES
RESIDENTIAL DESIGN

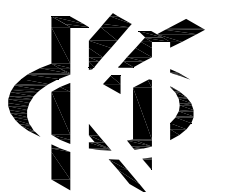

16125 ADAMS STREET
OMAHA, NEBRASKA 68135
(402) 895-6090

PROJ. NO.: 08001
DATE: 02.14.08
REVISION: PAGE NO.

A9