


NOTE: SEE PAGE A2 FOR ROOF PLAN, SIDE AND REAR ELEVATIONS

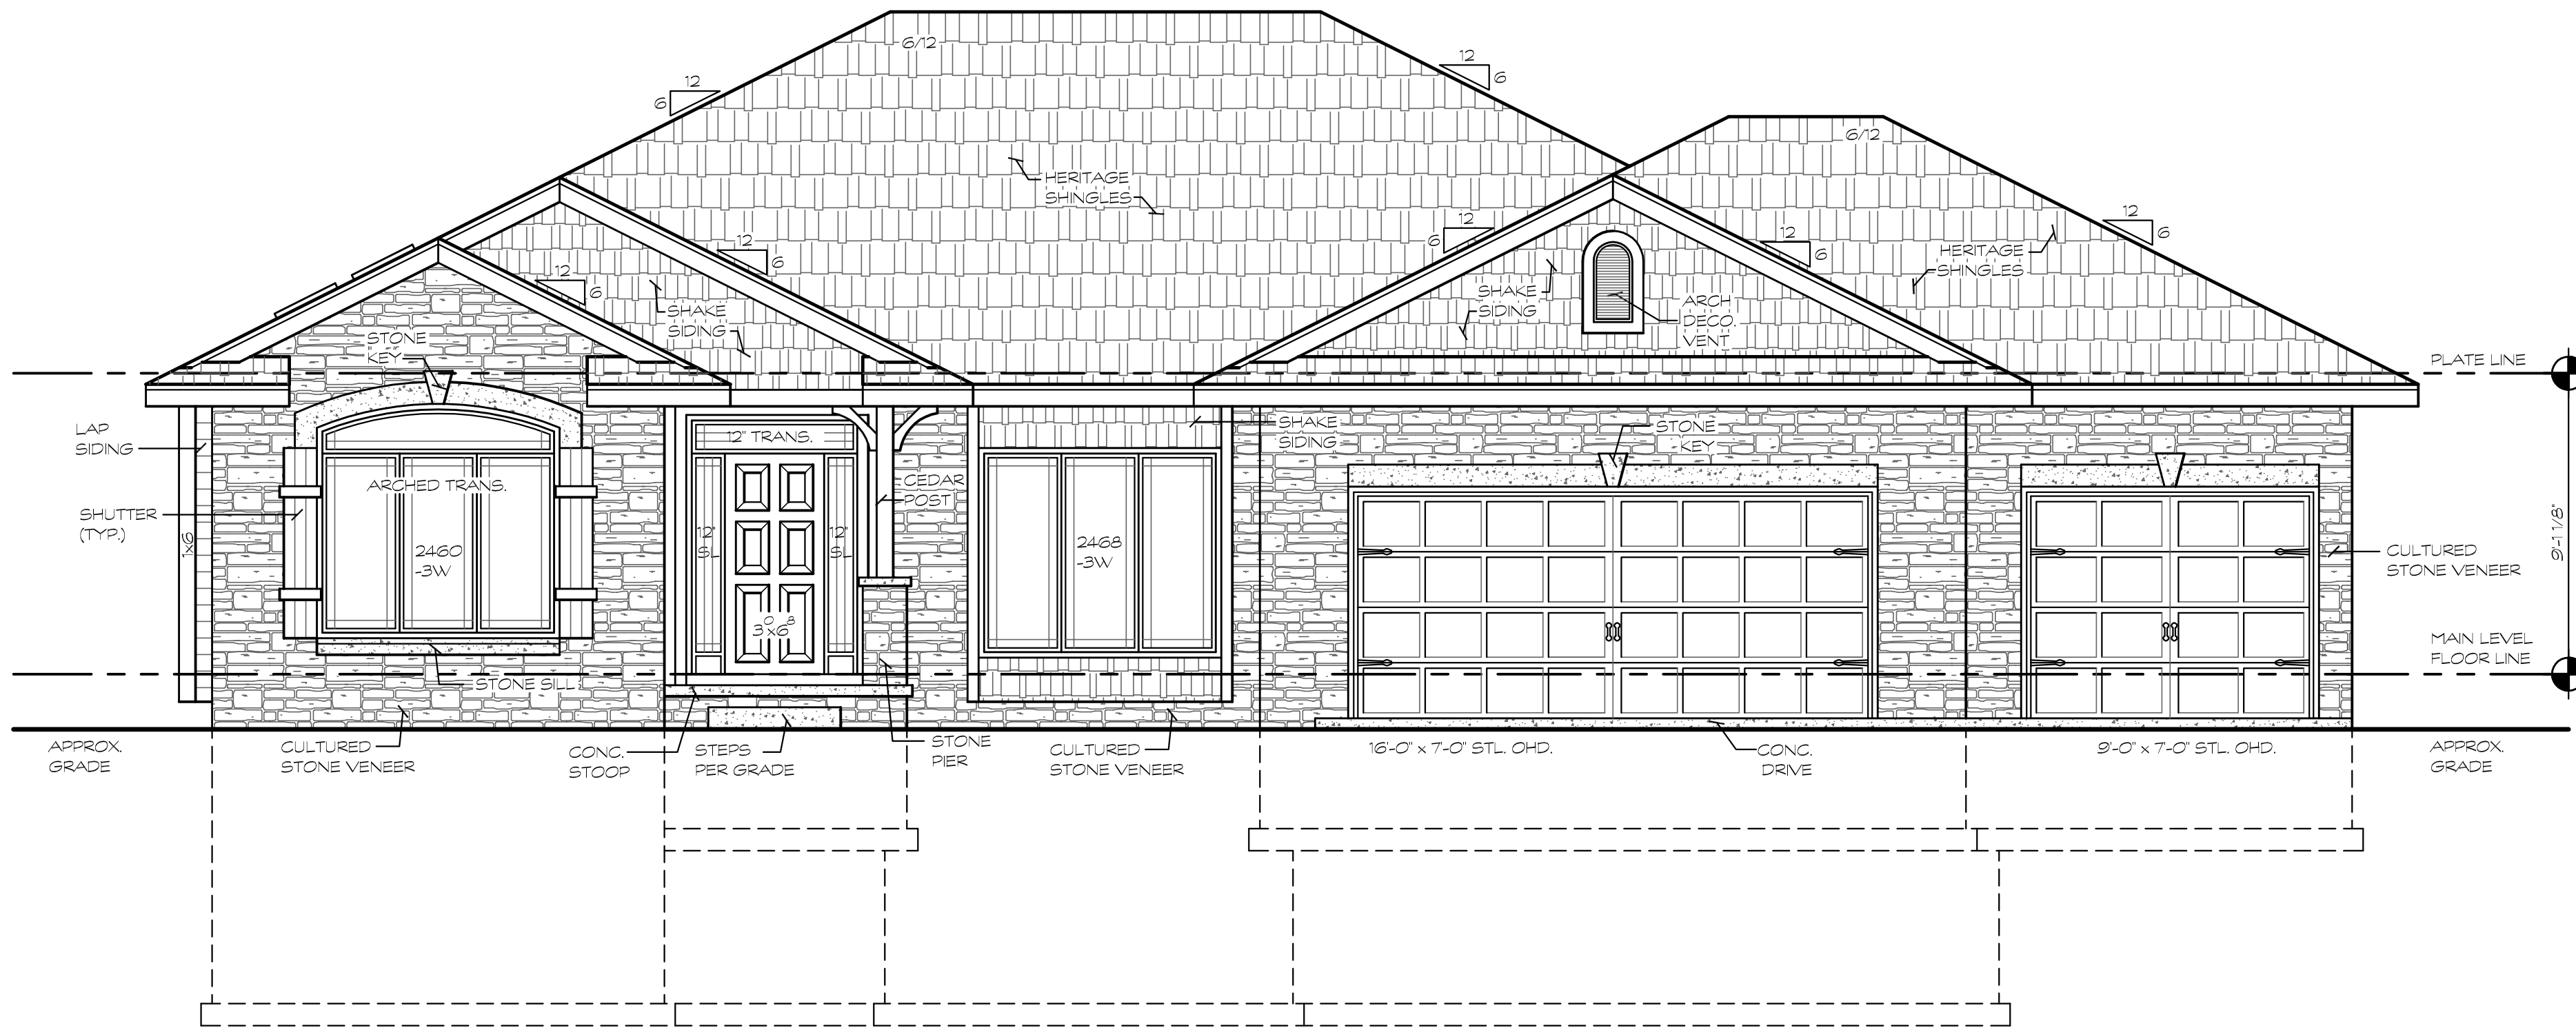

1 FRONT ELEVATION
SCALE: 1/4" = 1'-0"

NOTE:
1. PELLA TAN WINDOWS
2. SMOOTH CEILING IN DINING/
MASTER BEDROOM VAULT

SHEET INDEX


A1	FRONT ELEVATION	A6	SECTIONS / DETAILS
A2	SECONDARY ELEVATIONS / ROOF PLAN	A7	FRAMING DETAILS
A3	FOUNDATION PLAN	A8	DECK PLAN / DECK DETAILS
A4	BASEMENT FLOOR PLAN	A9	ELECTRICAL PLAN(S)
A5	MAIN LEVEL FLOOR PLAN		

ABBREVIATIONS

@	AT	CONC.	CONCRETE	FF	FINISHED FLOOR	MC	MEDICINE CABINET	SD	SMOKE DETECTOR
1R-15	ONE ROD ONE SHELF	CONT.	CONTINUOUS	F/G	FIBERGLASS	MICRO	MICROWAVE	SQ. FT.	SQUARE FOOT
2R-25	TWO RODS TWO SHELVES	DBL.	DOUBLE	FND	FOUNDATION	MIN	MINIMUM	SL	SIDE LIGHT
6S	SIX SHELVES	DF	DOUGLAS FIR	FTG.	FOOTING	MISC.	MISCELLANEOUS	SPF	SPRUCE PINE FIR
10S	TEN SHELVES	D.O.	DRYWALL OPENING	H.C.	HOLLOW CORE	N.I.C.	NOT IN CONTRACT	STD	STANDARD
ADJ.	ADJUSTABLE	D.S.	DOWN SPOUT	HDR	HEADER	NTS.	NOT TO SCALE	SYP	SOUTHERN YELLOW PINE
AFF.	ABOVE FINISHED FLOOR	DN.	DOWN	HF	HEM FIR	O.C.	ON CENTER	TEMP	TEMPERED
ALT.	ALTERNATE	EA.	EACH	INSUL.	INSULATION	OCT.	OCTAGON	T&G	TONGUE AND GROOVE
BLDG.	BUILDING	E.J.	EXPANSION JOINT	INT.	INTERIOR	OHD.	OVERHEAD DOOR	TOP	TOP OF PLATE
CAB.	CABINET	ENG.	ENGINEERED	LAV.	LAVATORY	OPNG.	OPENING	TYP.	TYPICAL
CLG.	CEILING	EQ.	EQUAL	LIN.	LINEN	PL.	PLATE	UL	UNDERLAYMENT
C.O.	CASED OPENING	EXT.	EXTERIOR	L.S.	LAZY SUSAN	R.	RADIUS	w/	WITH
COMP.	COMPOSITE	EXIST.	EXISTING	LVL	LAMINATED VENEER LUMBER	SC.	SOLID CORE	WD.	WOOD



KEN TINNES
RESIDENTIAL DESIGN

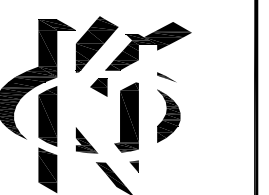

16125 ADAMS STREET
OMAHA, NEBRASKA 68135
(402) 895-6090

PROJ. NO.: 08001
DATE: 02.14.08
REVISION: PAGE NO.